

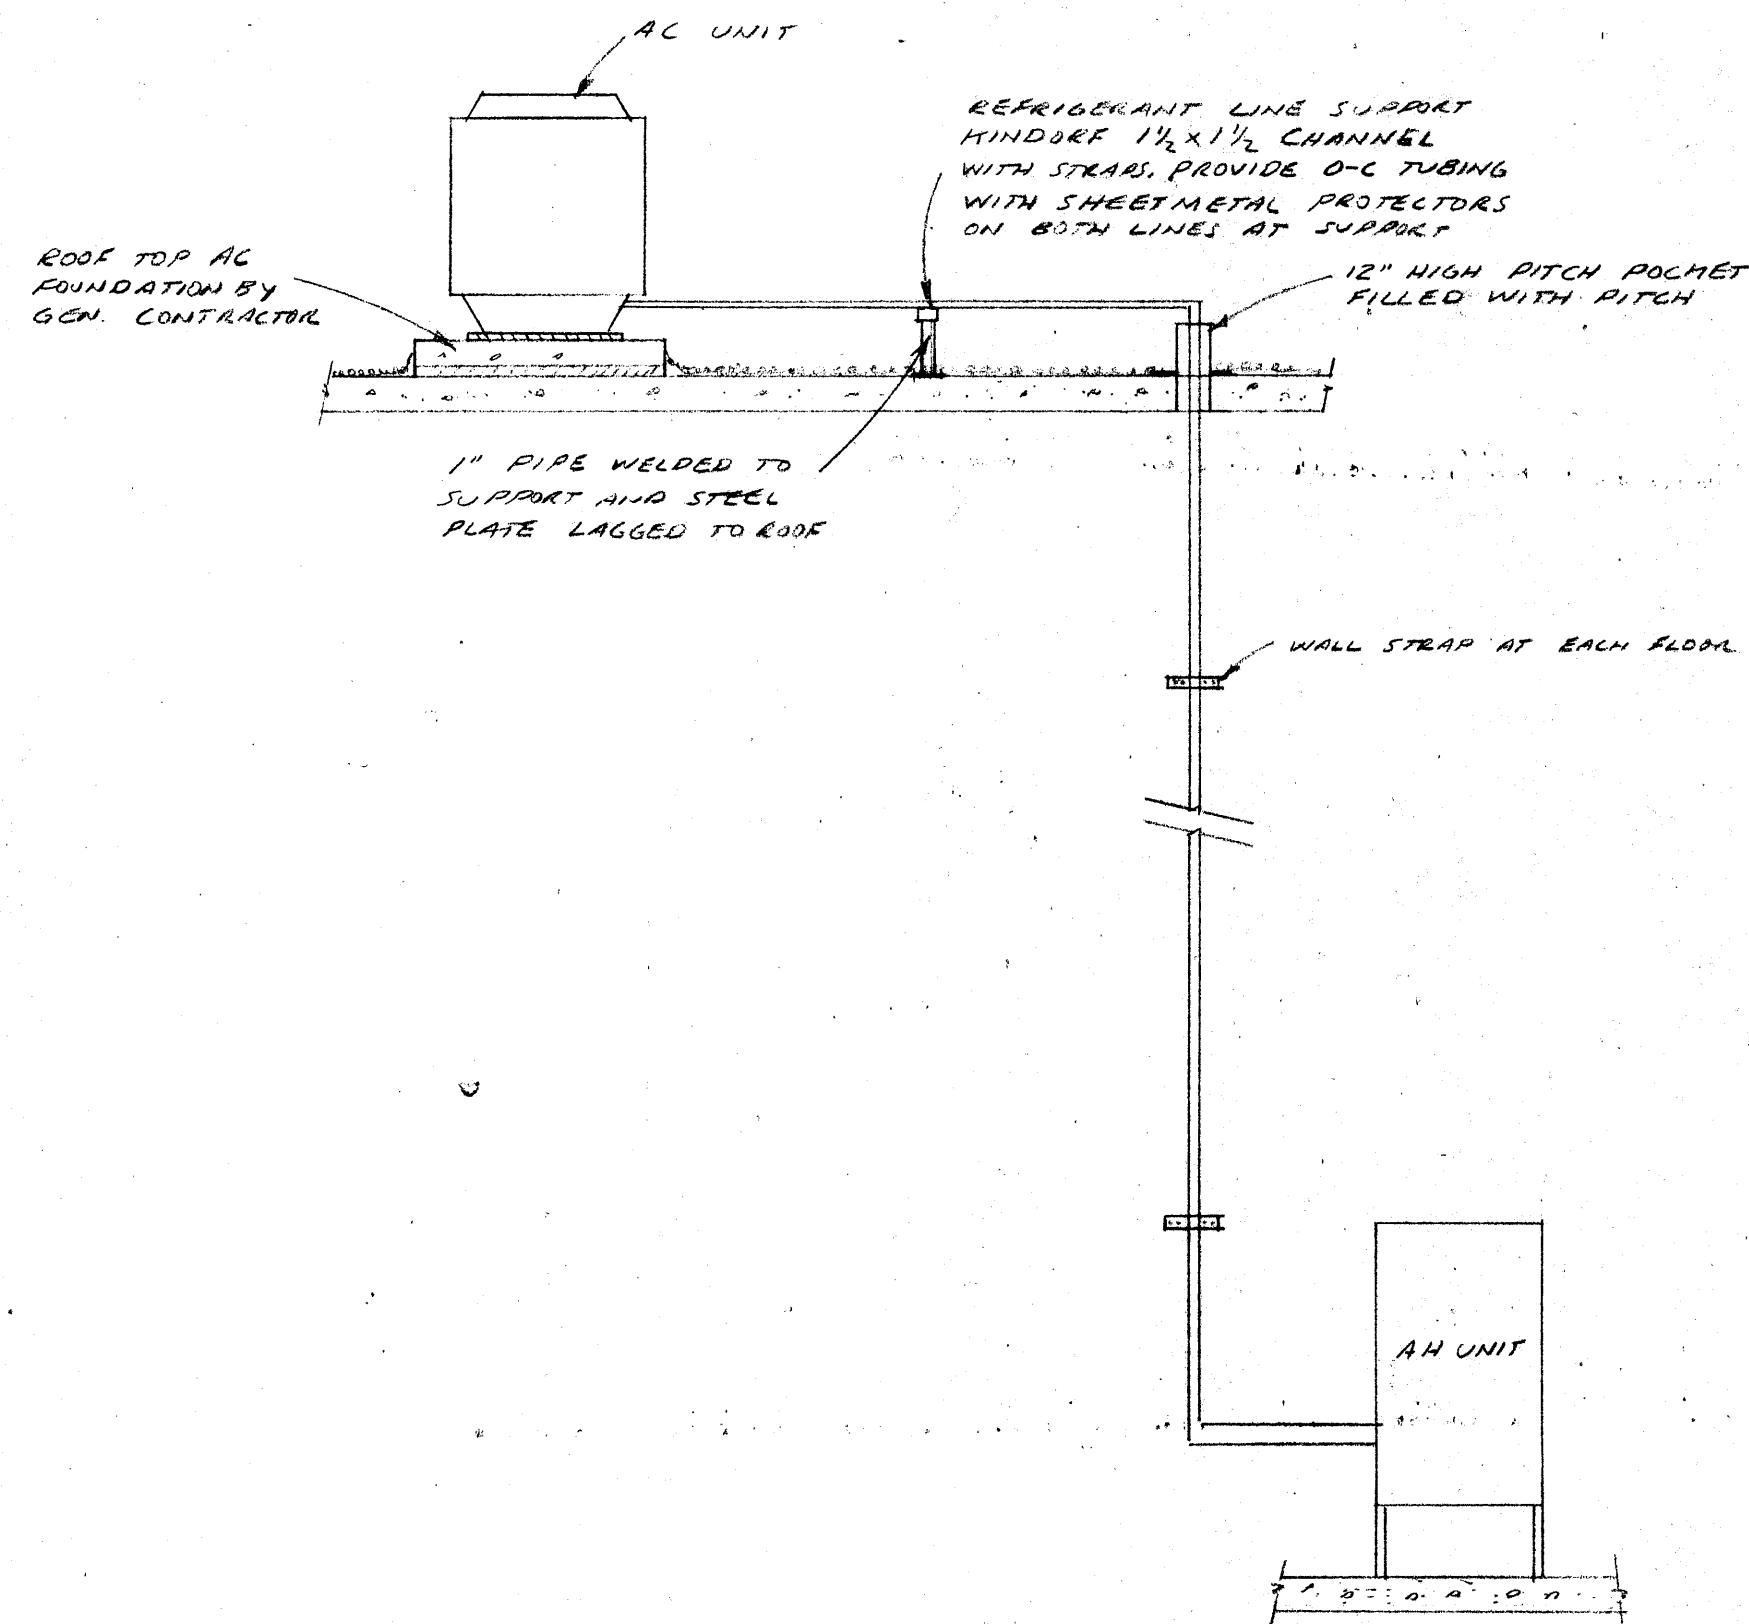


REFRIGERANT LINE SIZES		
APT. NO.	SUCTION LINE, O.D.	LIQUID LINE, O.D.
REG. RM.	7/8	3/8
503, 504	5/8	1/4
603, 604	5/8	1/4
703, 704	5/8	1/4
ALL OTHERS	3/4	3/8

PIPING NOTES:  
 1. INSTALL PIPING AS PER MFG'S RECOMMENDATION FOR HI-RISE CONSTRUCTION  
 2. INSULATE SUCTION LINE WITH 1/2" WALL O-C FLEX TUBE.

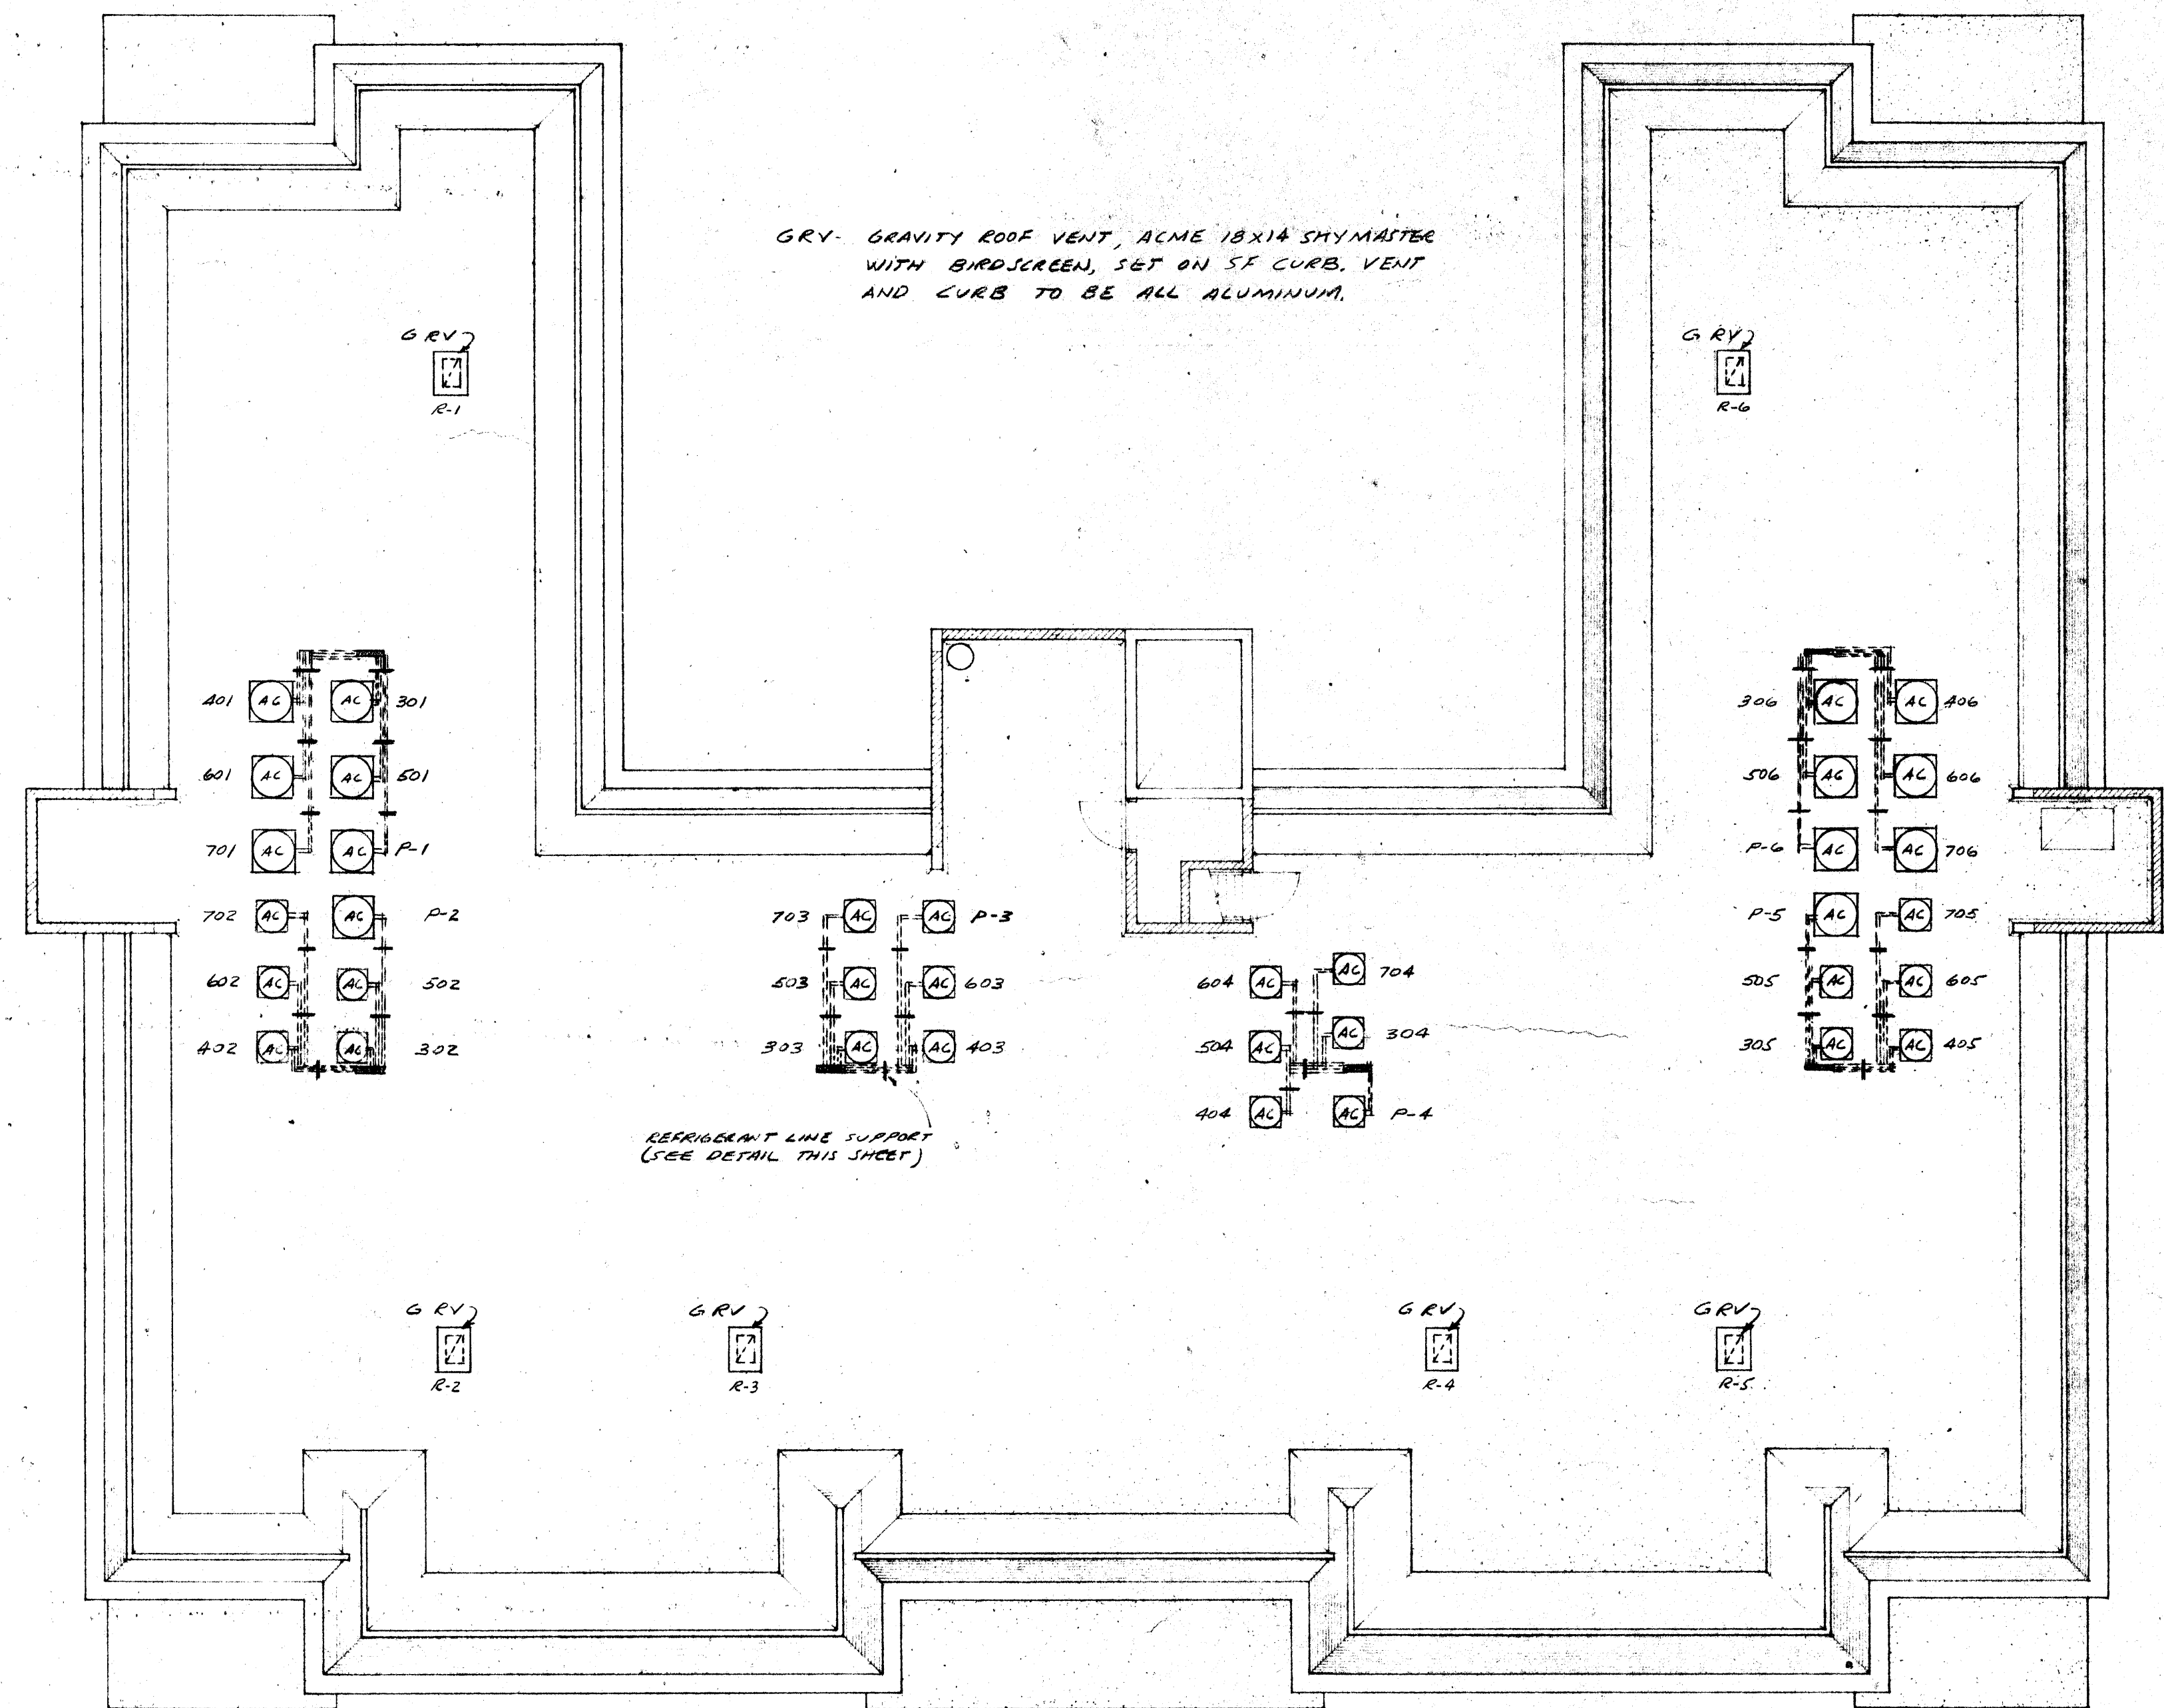

ROOF TOP REFRIGERANT PIPING  
 N.T.S.

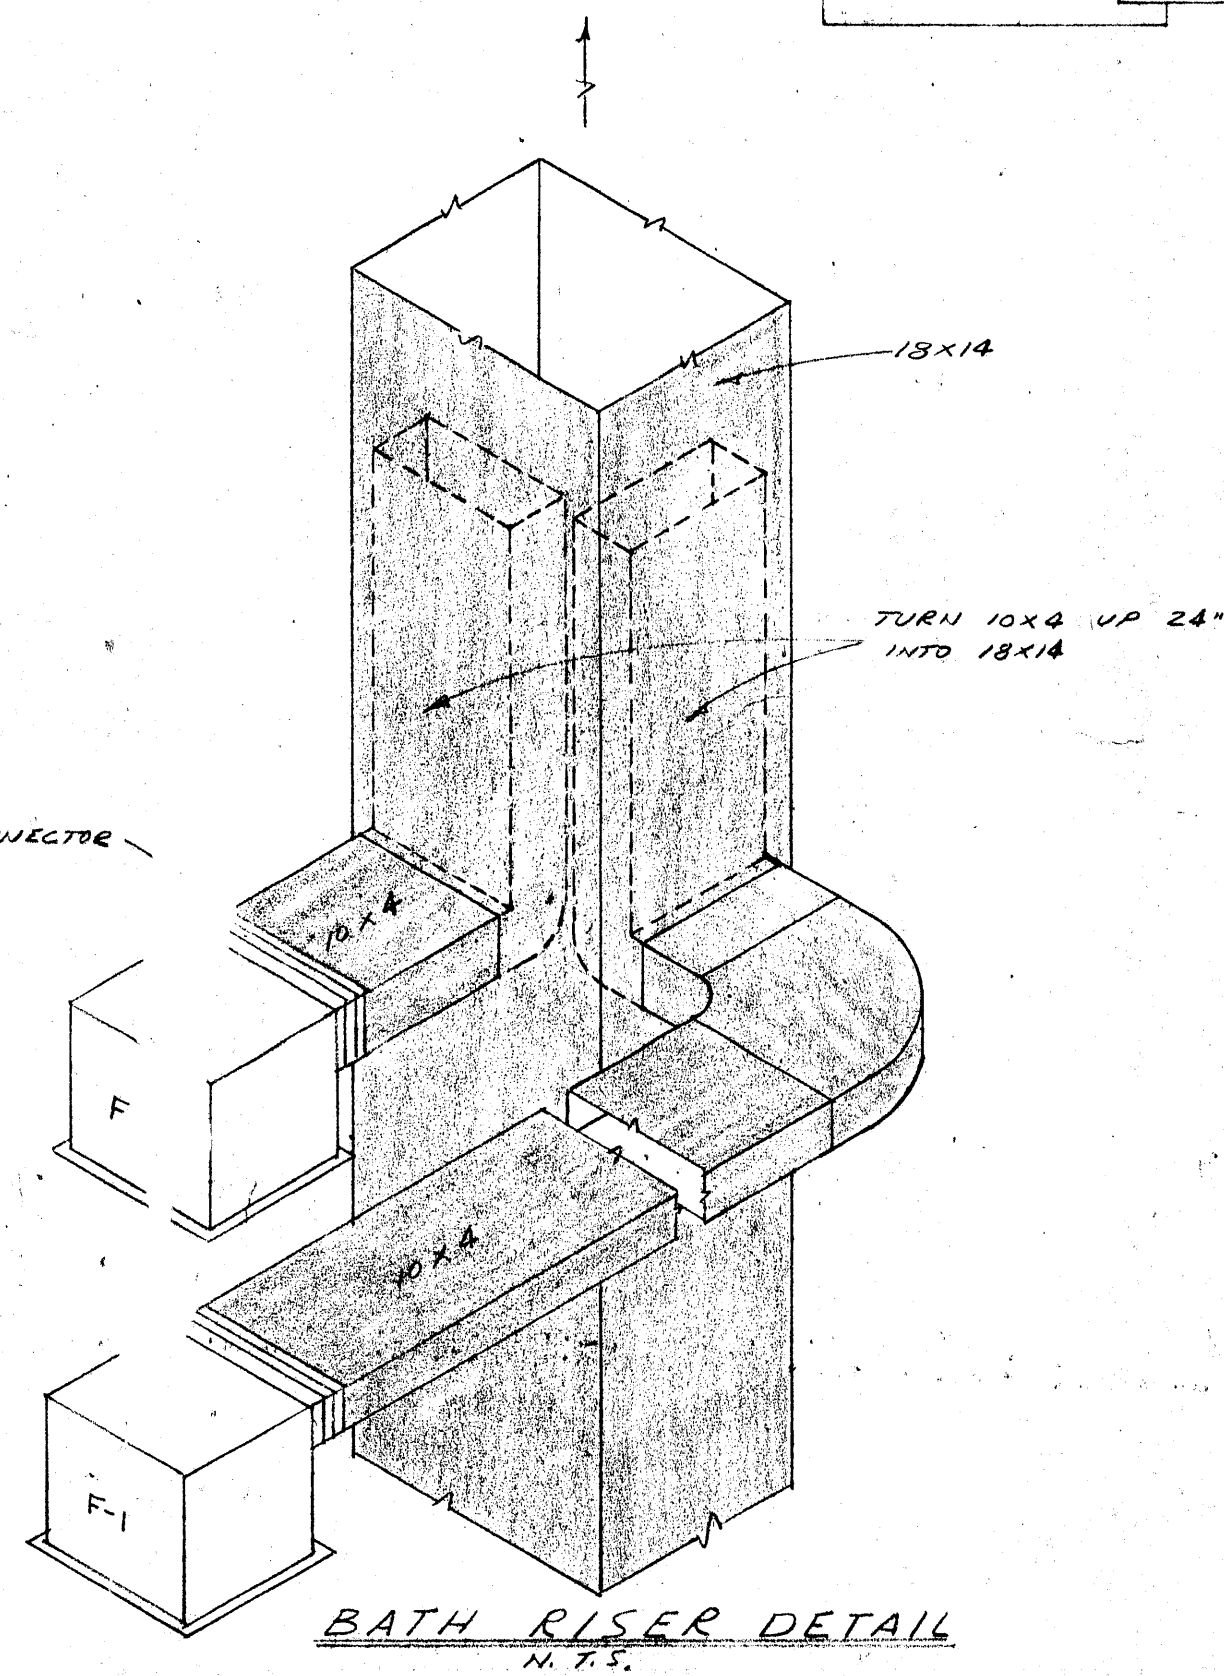

ROOF PLAN  
 SCALE 1/8" = 1'-0"