


LAUNDRY PANELBOARD PB-L SCHEDULE					
ITE EQ 442 B, 120/208 V-3P-4W, 5N, 200 A M.L.O. 42 SPACE FL. MOUNT					
CIRCUIT	VOLTS	POLES	BKR	WIRE	PURPOSE
L-1	120	1	20A	#12	1ST FL. LAUNDRY RECP.
L-2	DO	1	DO	DO	2ND FL. DO DO
L-3	DO	1	DO	DO	3RD FL. DO DO
L-4	DO	1	DO	DO	4TH FL. DO DO
L-5	DO	1	DO	DO	5TH FL. DO DO
L-6	DO	1	DO	DO	6TH FL. DO DO
L-7	DO	1	DO	DO	7TH FL. DO DO
L-8	DO	1	DO	DO	8TH FL. DO DO
L-9	DO	1	DO	DO	1ST FL. WASHER
L-10	DO	1	DO	DO	2ND FL. DO
L-11	DO	1	DO	DO	3RD FL. DO
L-12	DO	1	DO	DO	4TH FL. DO
L-13	DO	1	DO	DO	5TH FL. DO
L-14	DO	1	DO	DO	6TH FL. DO
L-15	DO	1	DO	DO	7TH FL. DO
L-16	DO	1	DO	DO	8TH FL. DO
L-17	DO	1	DO	DO	1ST-8TH FL LAUNDRY LIGHTS
L-18	208	2	30A	#10	2ND FL. 4.5 KW WATER HTR
L-19	DO	2	DO	DO	4TH FL. DO DO DO
L-20	DO	2	DO	DO	6TH FL. DO DO DO
L-21	DO	2	DO	DO	8TH FL. DO DO DO
L-22	DO	2	DO	DO	1ST FL. 5.6 KW DRYER
L-23	DO	2	DO	DO	2ND FL. DO DO
L-24	DO	2	DO	DO	3RD FL. DO DO
L-25	DO	2	DO	DO	4TH FL. DO DO
L-26	DO	2	DO	DO	5TH FL. DO DO
L-27	DO	2	DO	DO	6TH FL. DO DO
L-28	DO	2	DO	DO	7TH FL. DO DO
L-29	DO	2	DO	DO	8TH FL. DO DO

NOTES:
 1. ALL CONDUCTORS TO BE COPPER. ALUMINUM IS NOT ACCEPTABLE.
 2. NO MORE THAN 3 CONDUCTORS TO BE RUN IN A SINGLE CONDUIT WITHOUT INCREASING WIRE SIZE TO OFF SET DERATING FACTOR.

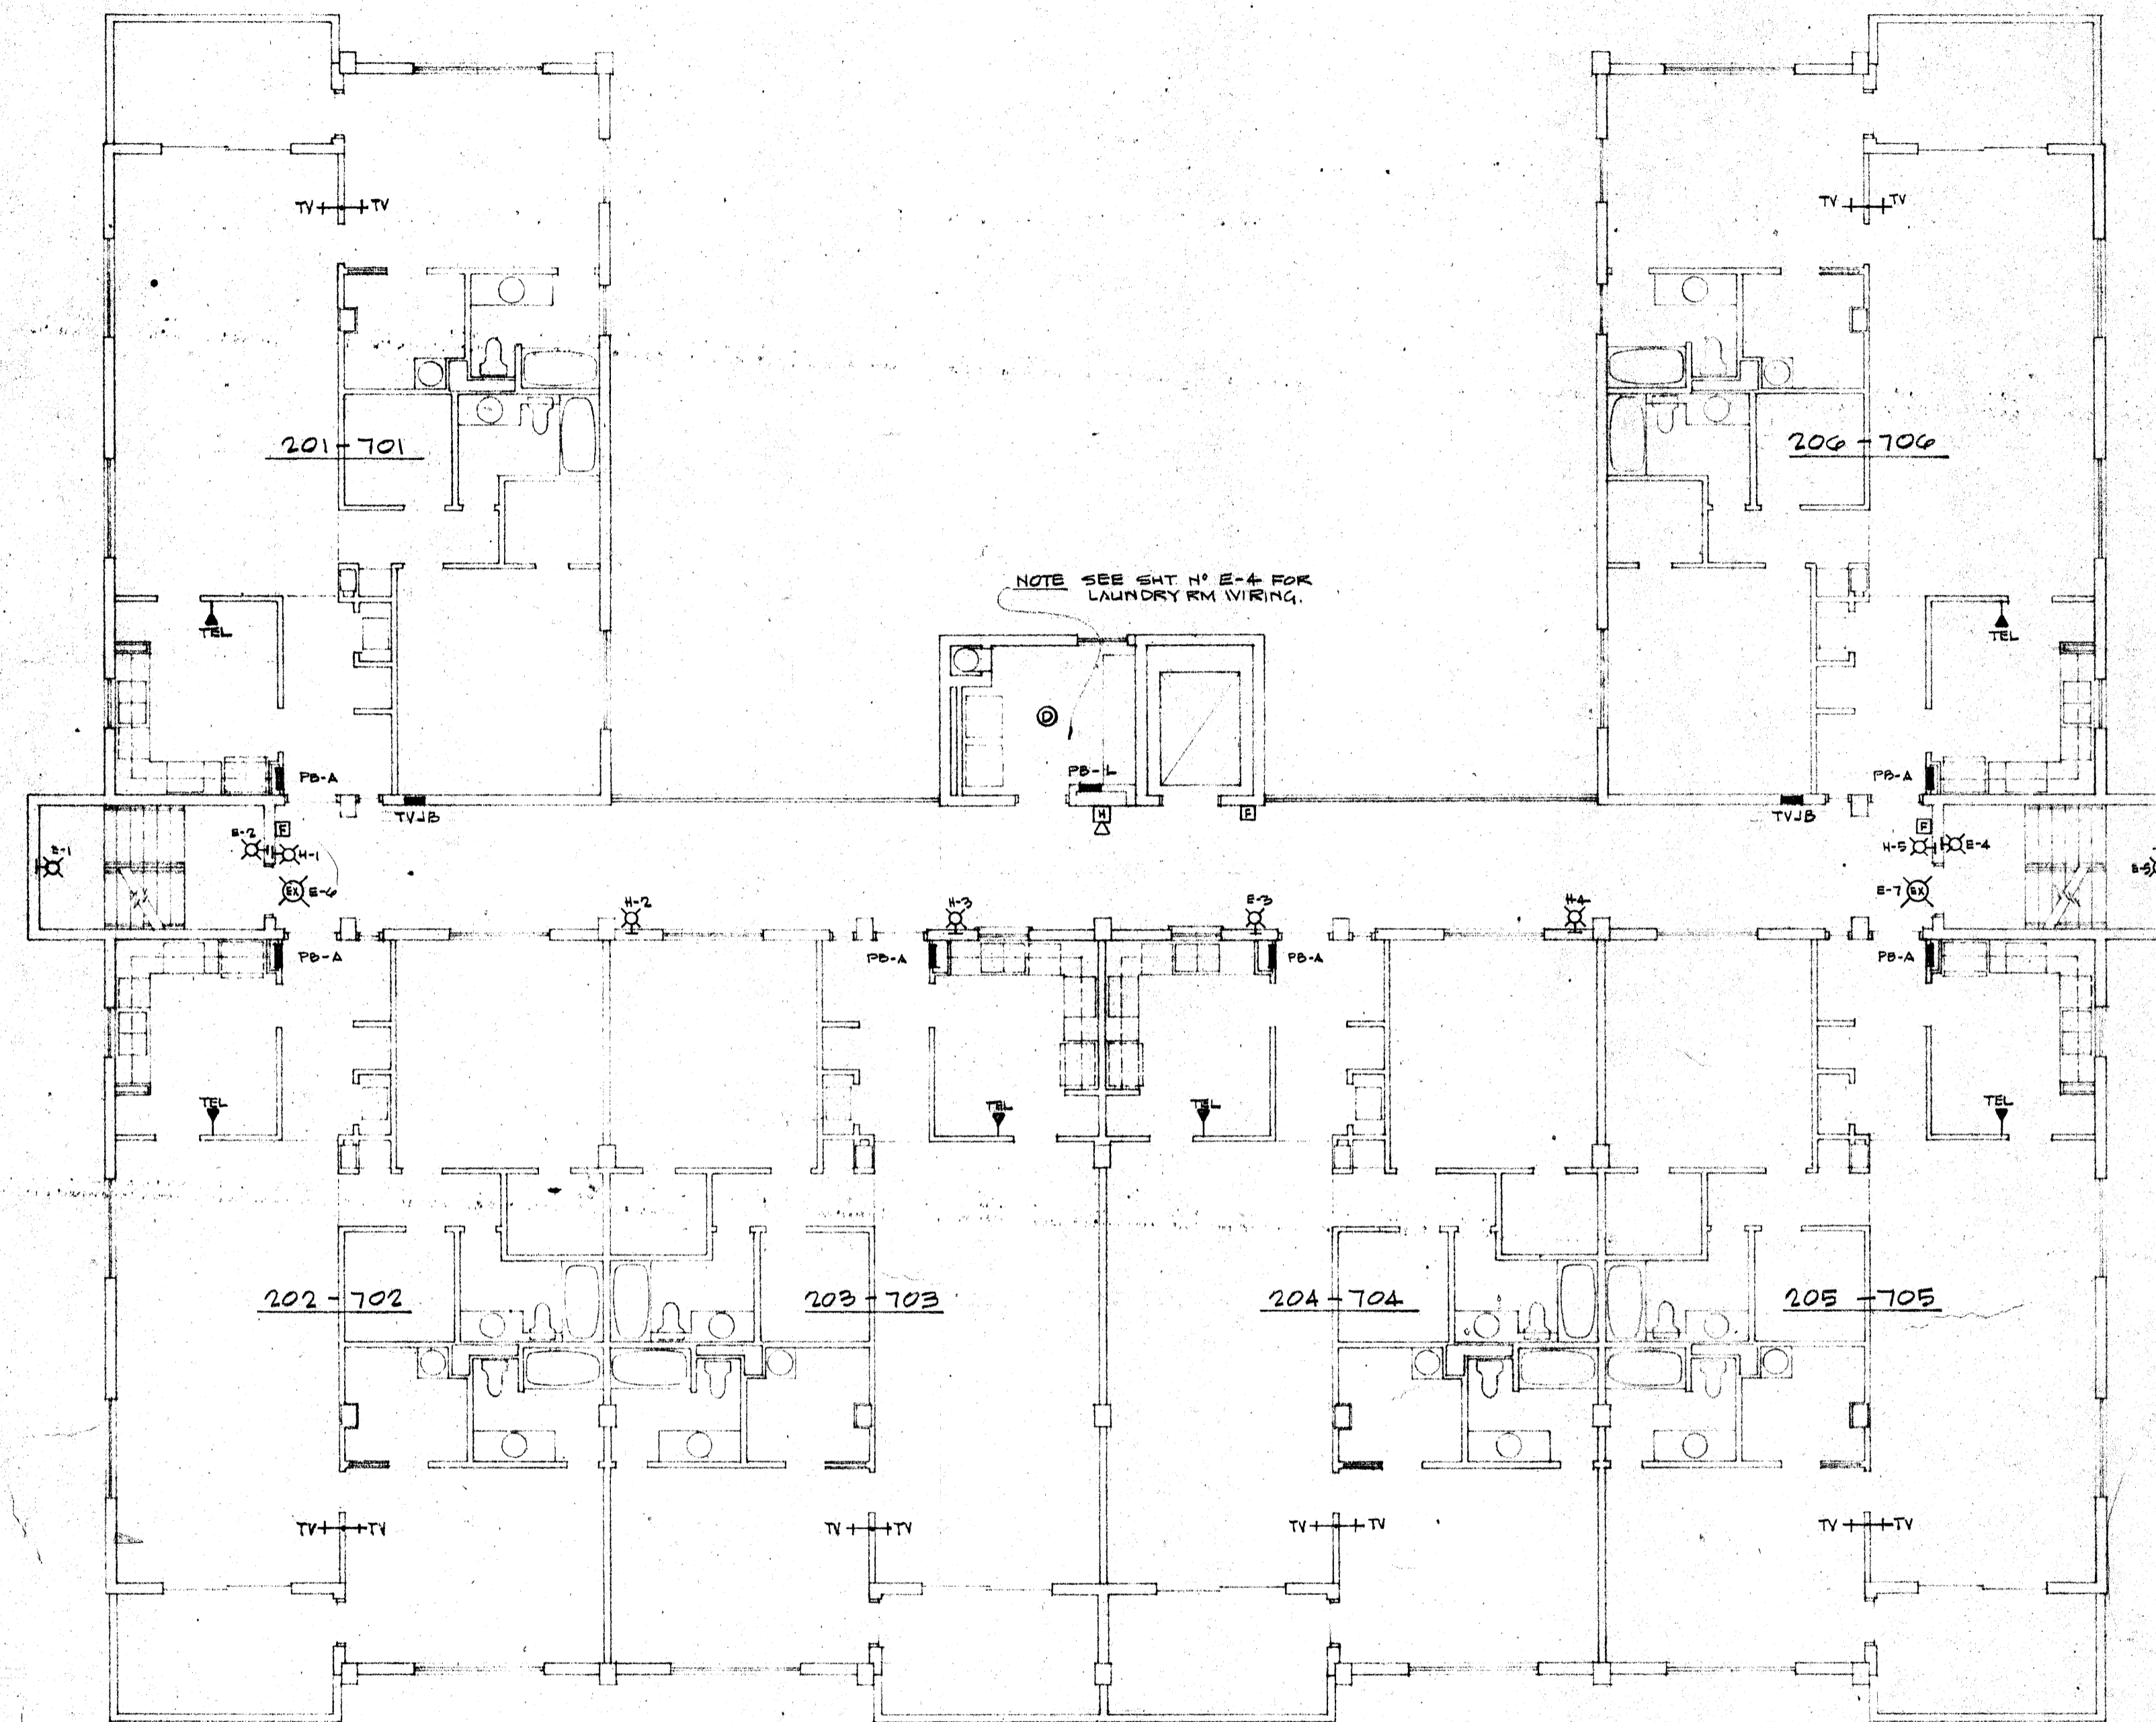

TYPICAL FLOOR ELECTRICAL PLAN FLOORS 2 THROUGH 7 - 3RD FLOOR SHOWN
 SCALE 1/8" = 1'-0"