



ROOF STORAGE  
SCALE 1/4" = 1'-0"

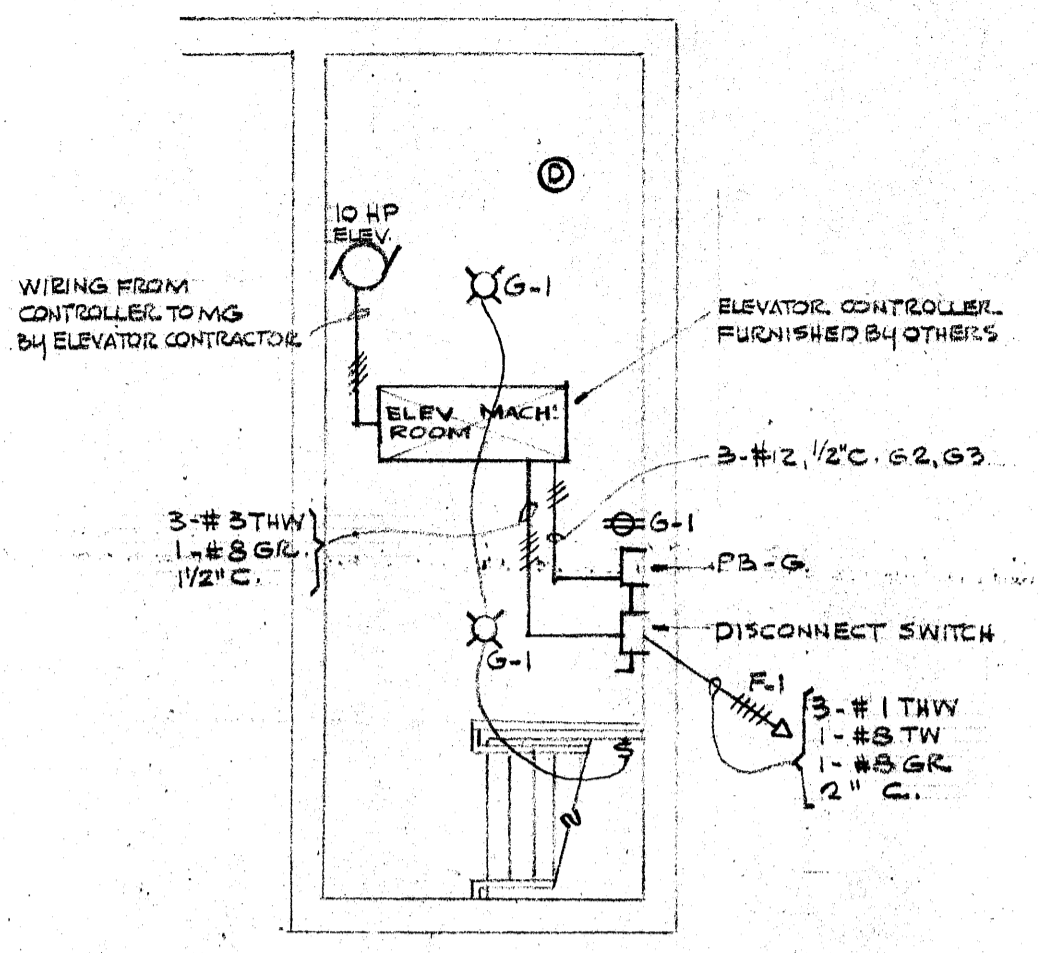


ELEV. MACH. ROOM  
SCALE 1/4" = 1'-0"

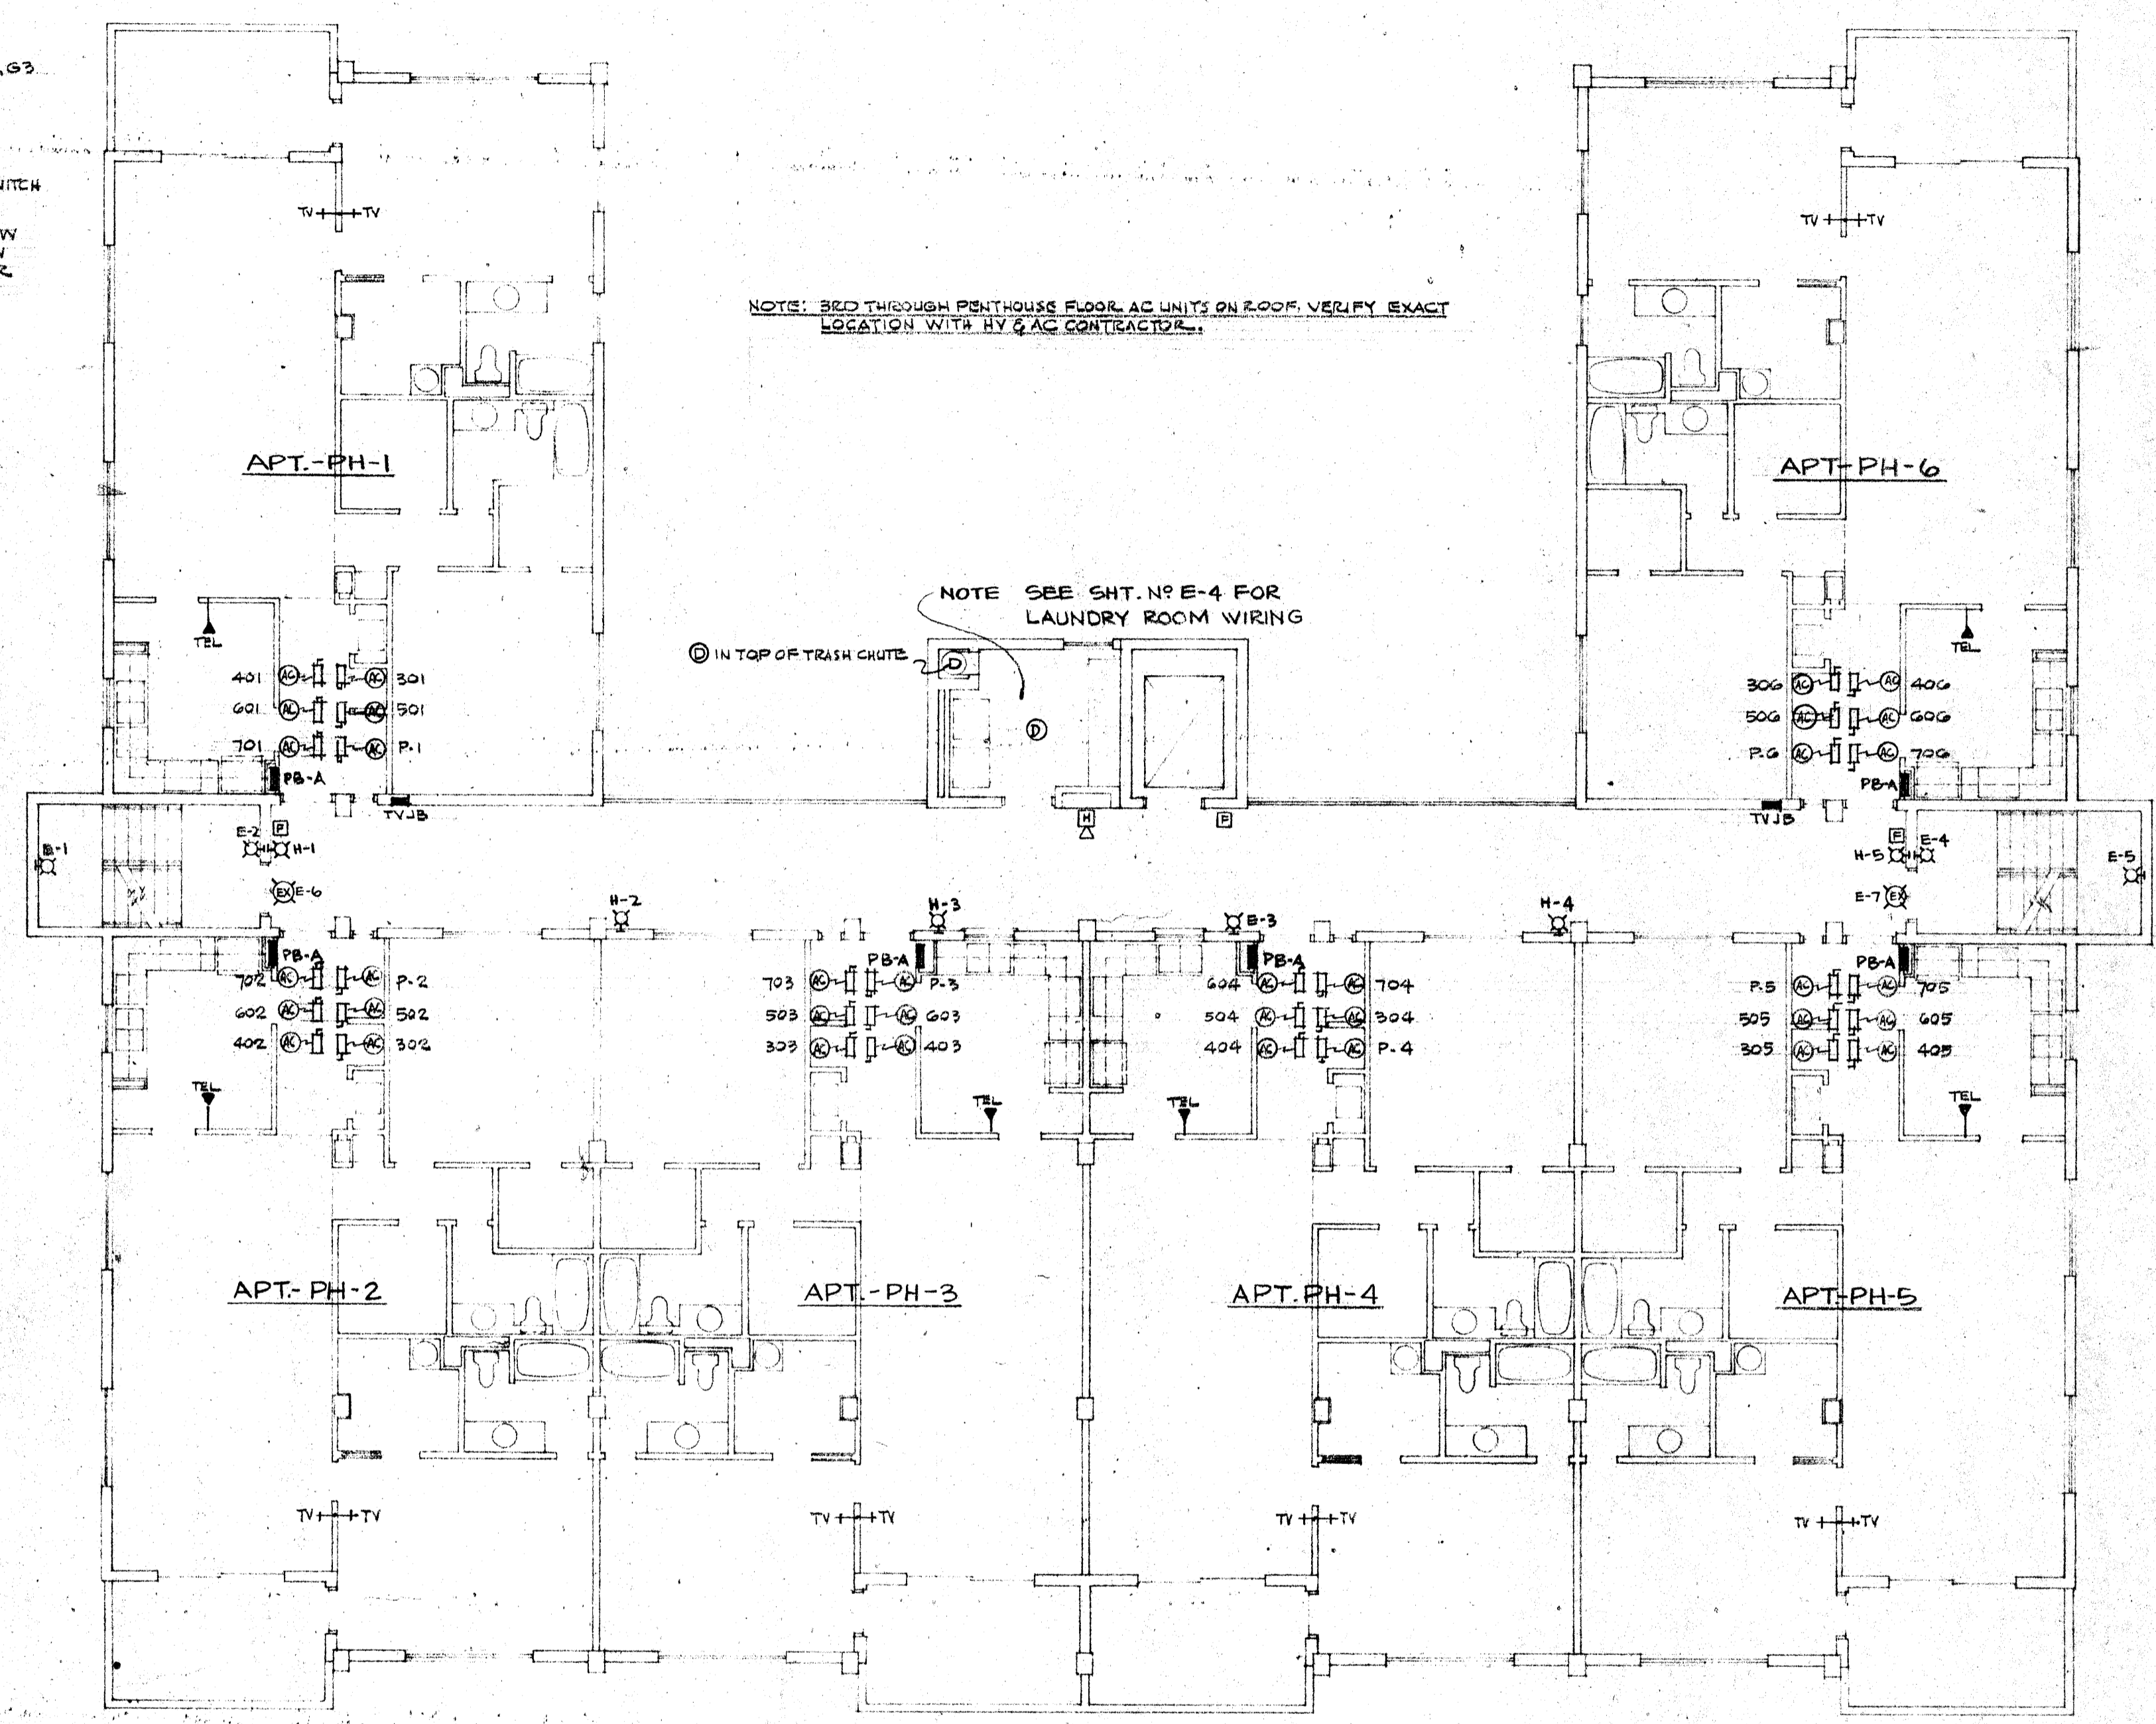

NOTE: BRD THROUGH PENTHOUSE FLOOR AC UNITS ON ROOF. VERIFY EXACT LOCATION WITH HV & AC CONTRACTOR.

NOTE SEE SHT. NO E-4 FOR LAUNDRY ROOM WIRING

⊙ IN TOP OF TRASH CHUTE

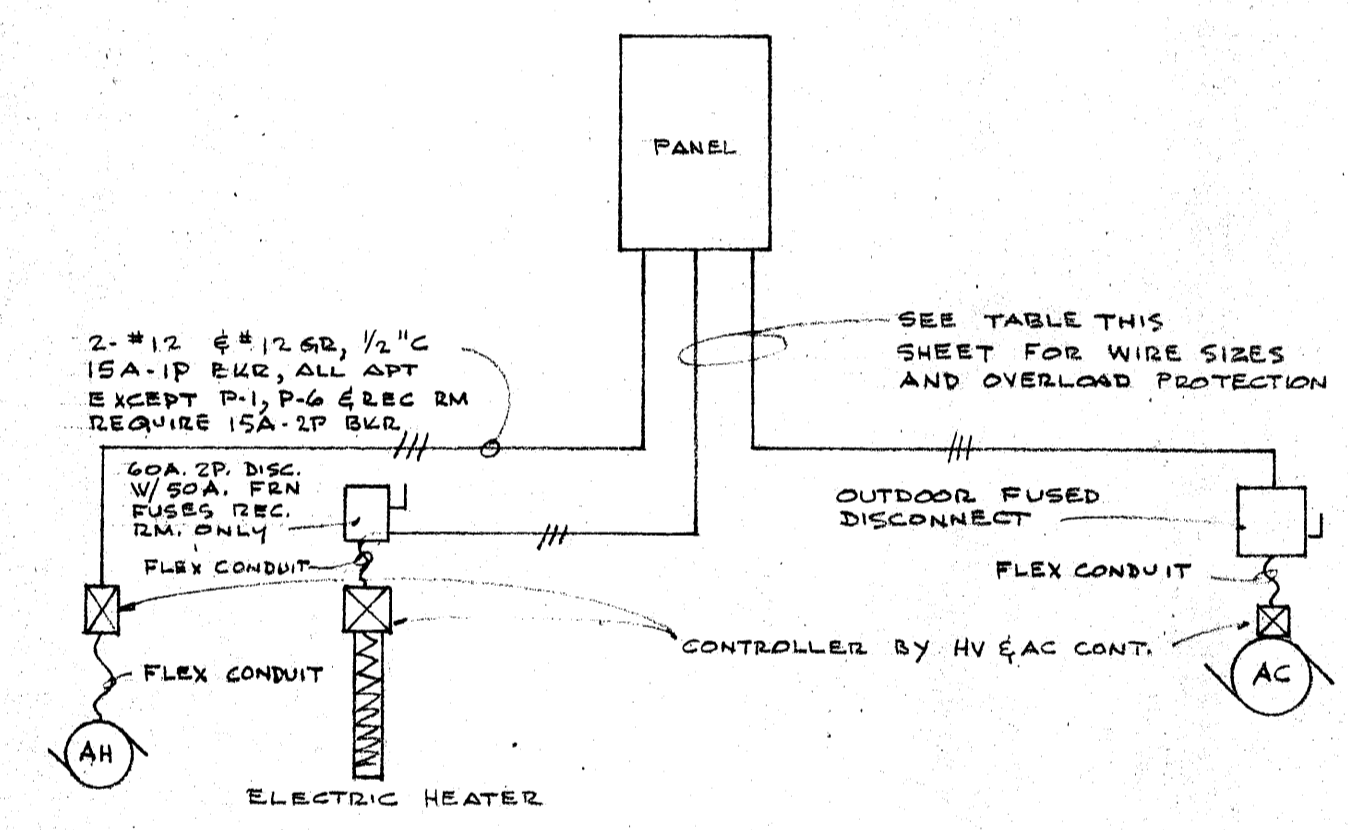

TYPICAL HEATING & AIR CONDITIONING WIRING  
N.T.S.

APARTMENT NO.	ELECTRIC HEATER				OUTDOOR AC UNIT					
	BREAKER	WIRE	CONDUIT	GR.	BREAKER	WIRE	CONDUIT	GR.	DISCONNECT	FUSES
G-1, G-6, P-2, P-5	70A-2P	#4THW	1 1/4"	#6	40A-2P	#8TW	3/4"	#10	60A-2P	35A
G-2, G-5, 201-501, 206-506	60A-2P	#6THW	1"	#10	40A-2P	#8TW	3/4"	#10	30A-2P	30A
G-3	40A-2P	#8TW	3/4"	#10	30A-2P	#8TW	3/4"	#10	30A-2P	25A
G-4, 203, 204, 303, 304, 403, 404	50A-2P	#6TW	1"	#10	30A-2P	#8TW	3/4"	#10	30A-2P	25A
201-501, 206-506	70A-2P	#4THW	1 1/4"	#8	40A-2P	#8TW	3/4"	#10	30A-2P	30A
601, 606, 701, 706	70A-2P	#4THW	1 1/4"	#8	40A-2P	#10TW	3/4"	#10	30A-2P	30A
602, 605, 702, 705, P3, P4	60A-2P	#6THW	1"	#10	40A-2P	#10TW	3/4"	#10	30A-2P	30A
503, 504, 603, 604, 703, 704	50A-2P	#6TW	1"	#10	30A-2P	#10TW	3/4"	#10	30A-2P	25A
P-1, P-6	90A-2P	#4THW	1 1/4"	#8	50A-2P	#8TW	3/4"	#10	60A-2P	45A
RECREATION RM	50A-3P	#6TW	1"	#10	40A-3P	#8THW	1"	#10	60A-3P	35A

NOTE: FUSES ARE BUSS TIME DELAY TYPE FRN

PENTHOUSE FLOOR ELECTRICAL PLAN  
SCALE 1/8" = 1'-0"

HOUSE PANEL BOARD PB-G SCHEDULE					
ITE. EQ. 4 120/208V 2P. 3W 5N, 100A M.L.C. 4-1P SPACES 500FACE MOUNT					
CIRCUIT	VOLTS	POLES	BKR	WIRE	PURPOSE
G-1	120	1	20A	#12	ELEV. RM. LIGHTS
G-2	110	1	11	11	ELEV. CAR LIGHTS
G-3	110	1	11	11	ELEV. SIGNALS

NOTES:  
1. ALL CONDUCTORS TO BE COPPER, ALUMINUM IS NOT ACCEPTABLE.  
2. NO MORE THAN 3 CONDUCTORS TO BE RUN IN A SINGLE CONDUIT WITHOUT INCREASING WIRE SIZE TO OFFSET DERATING FACTOR.