



REFRIGERANT LINE SIZES		
APP. NO.	SUCTION LINE, O.D.	LIQUID LINE, O.D.
REC. RM.	7/8	3/8
503, 504	5/8	1/4
603, 604	5/8	1/4
703, 704	5/8	1/4
ALL OTHERS	3/4	3/8


PIPING NOTES:  
 1. INSTALL PIPING AS PER MFG'S RECOMMENDATION FOR HI-RISE CONSTRUCTION  
 2. INSULATE SUCTION LINE WITH 1/2" WALL O-C FLEX TUBE.

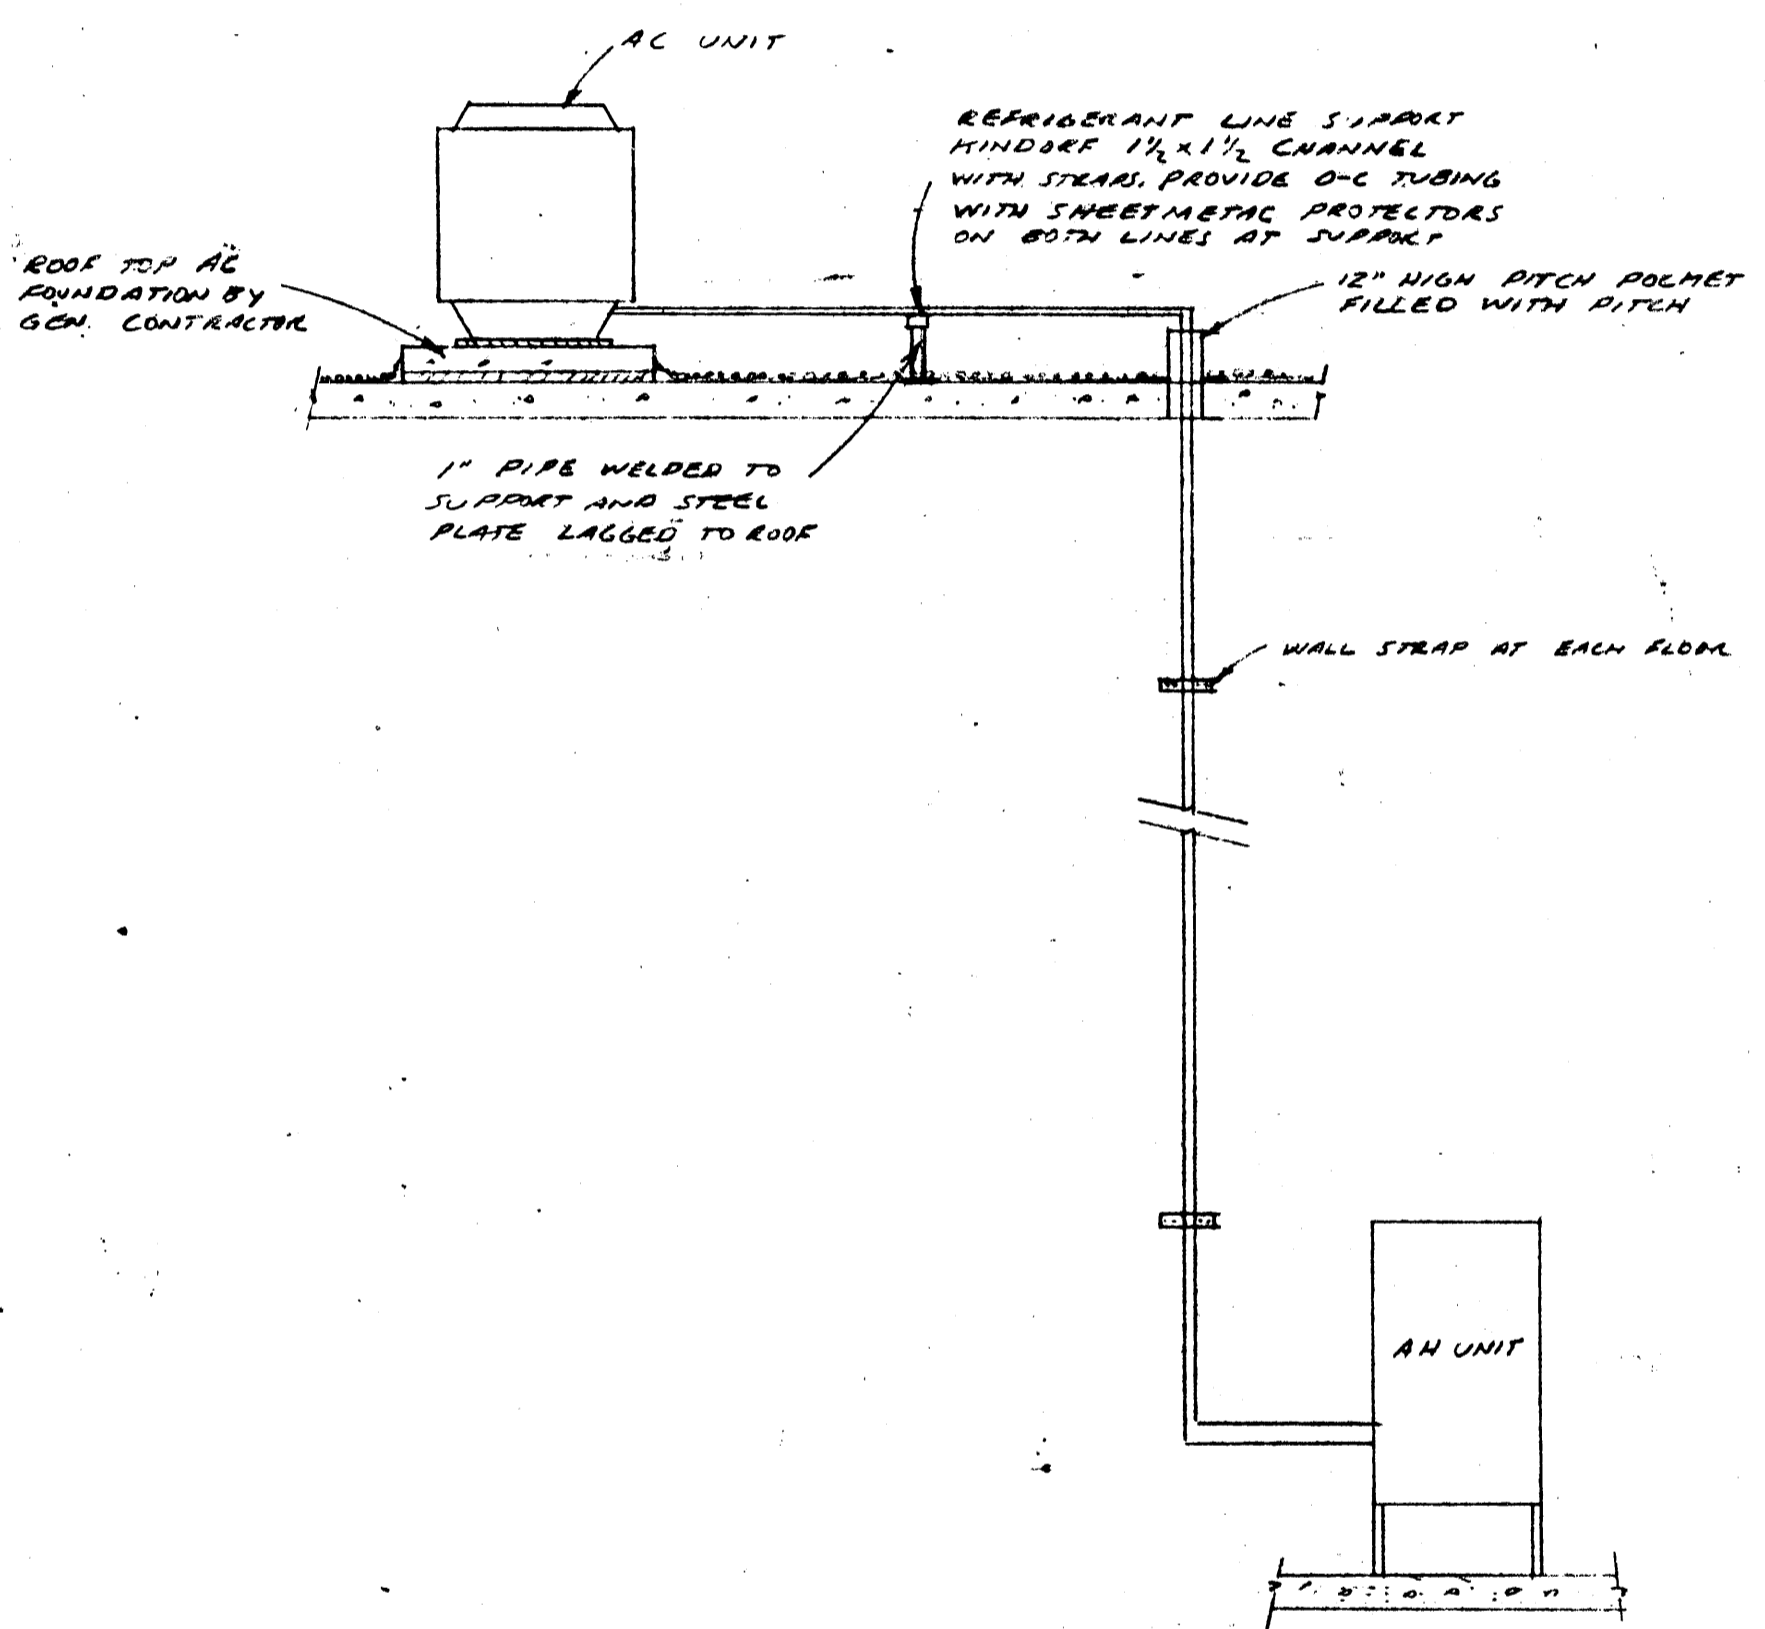

ROOF TOP REFRIGERANT PIPING  
N.T.S.

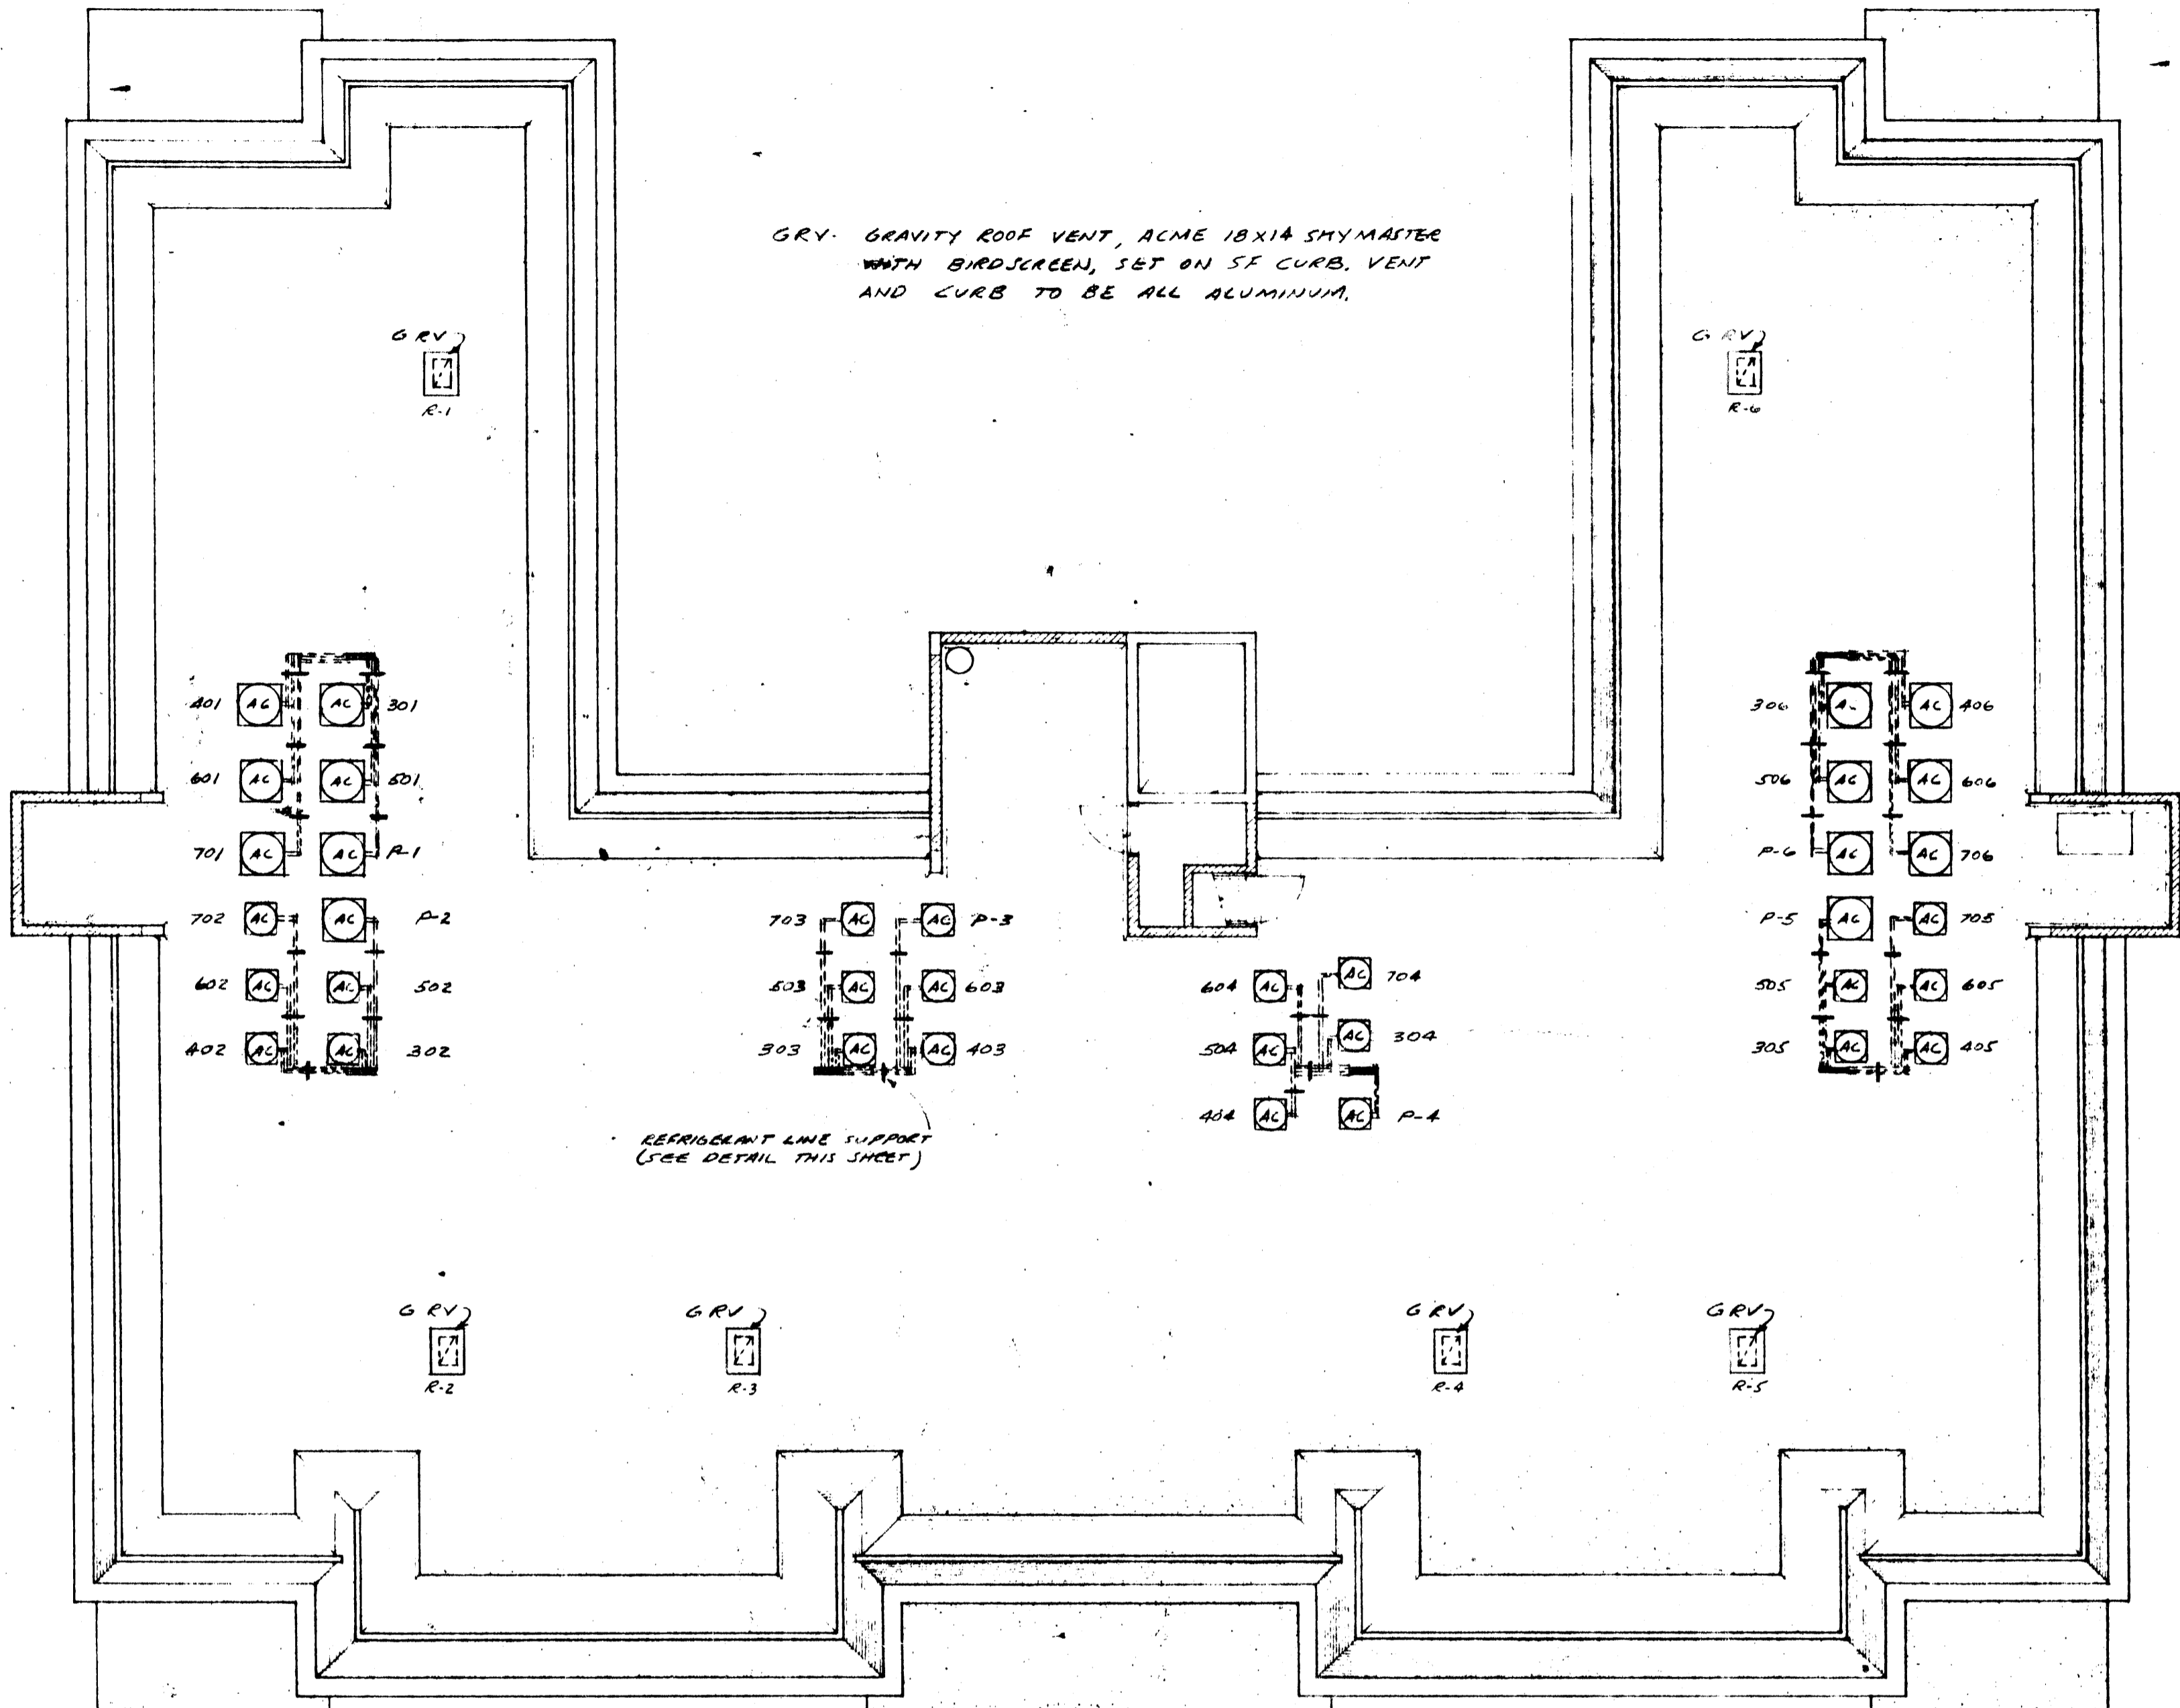

ROOF PLAN  
SCALE 1/8" = 1'-0"

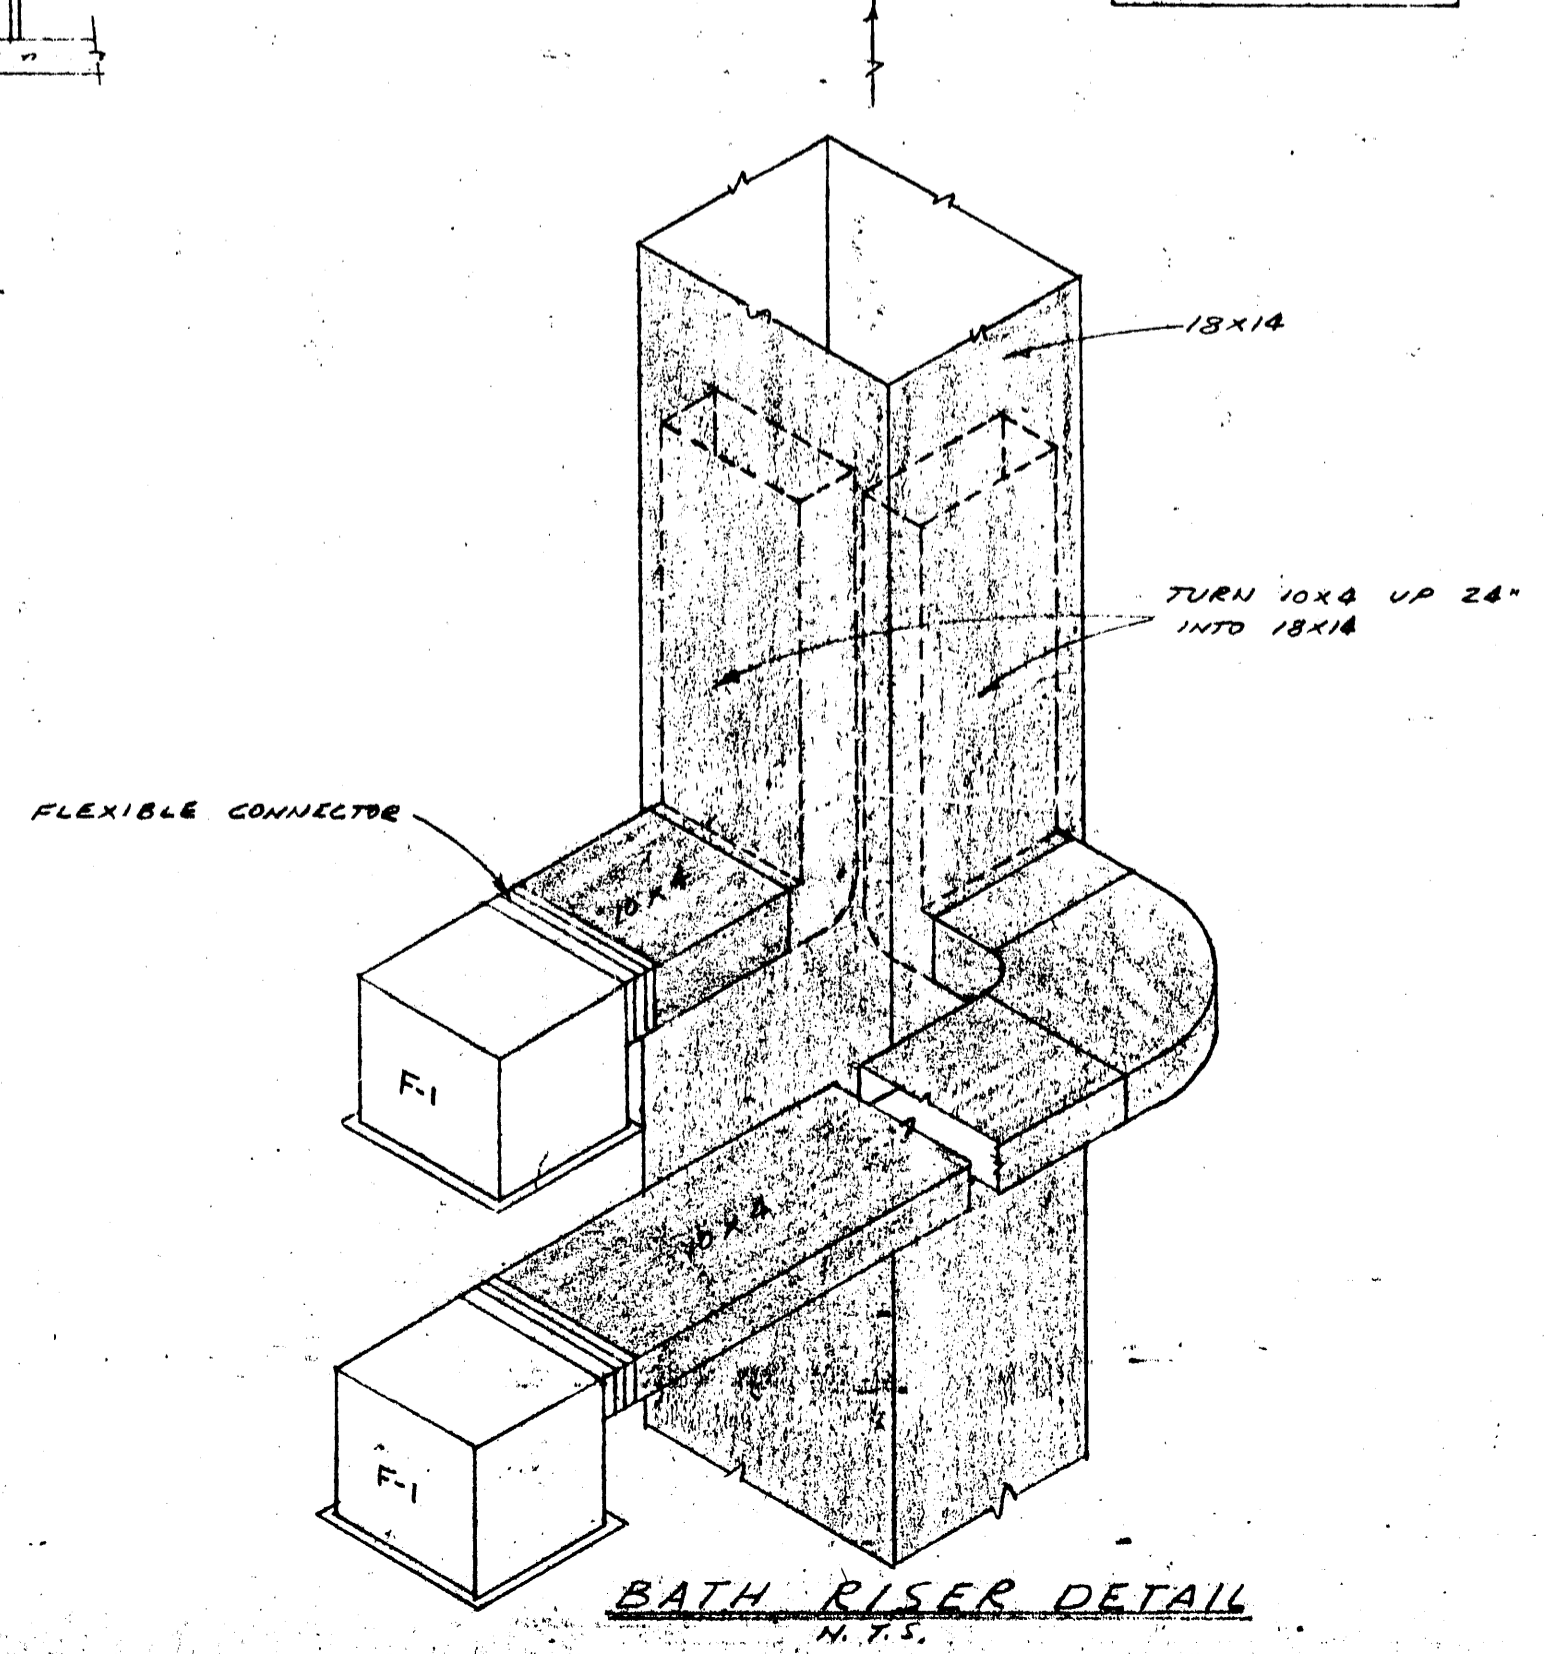

C. W. WHIDDEN  
CONSULTING ENGINEER

ACADA 11-17-70

DATE  
DEC. 1, 1970  
REVISIONS

ROBERT L. SHAW, A.I.A.  
ARCHITECT, INC.  
SARASOTA, FLORIDA

THE RIVERVIEW FOR FIRST MANATEE CORP.  
1400 FIRST AVENUE WEST - BRADENTON FLORIDA

ROOF AC UNIT PLAN

SHEET NO.  
M-2

