


CARPORT

DATE: \_\_\_\_\_  
 DRAWING NO.: \_\_\_\_\_  
 PROJECT: \_\_\_\_\_

THE RIVERVIEW FOR FIRST MANATEE CORP.  
 1400 FIRST AVENUE WEST - BRADENTON FLORIDA

GROUND FLOOR PLUMBING PLAN & RISERS

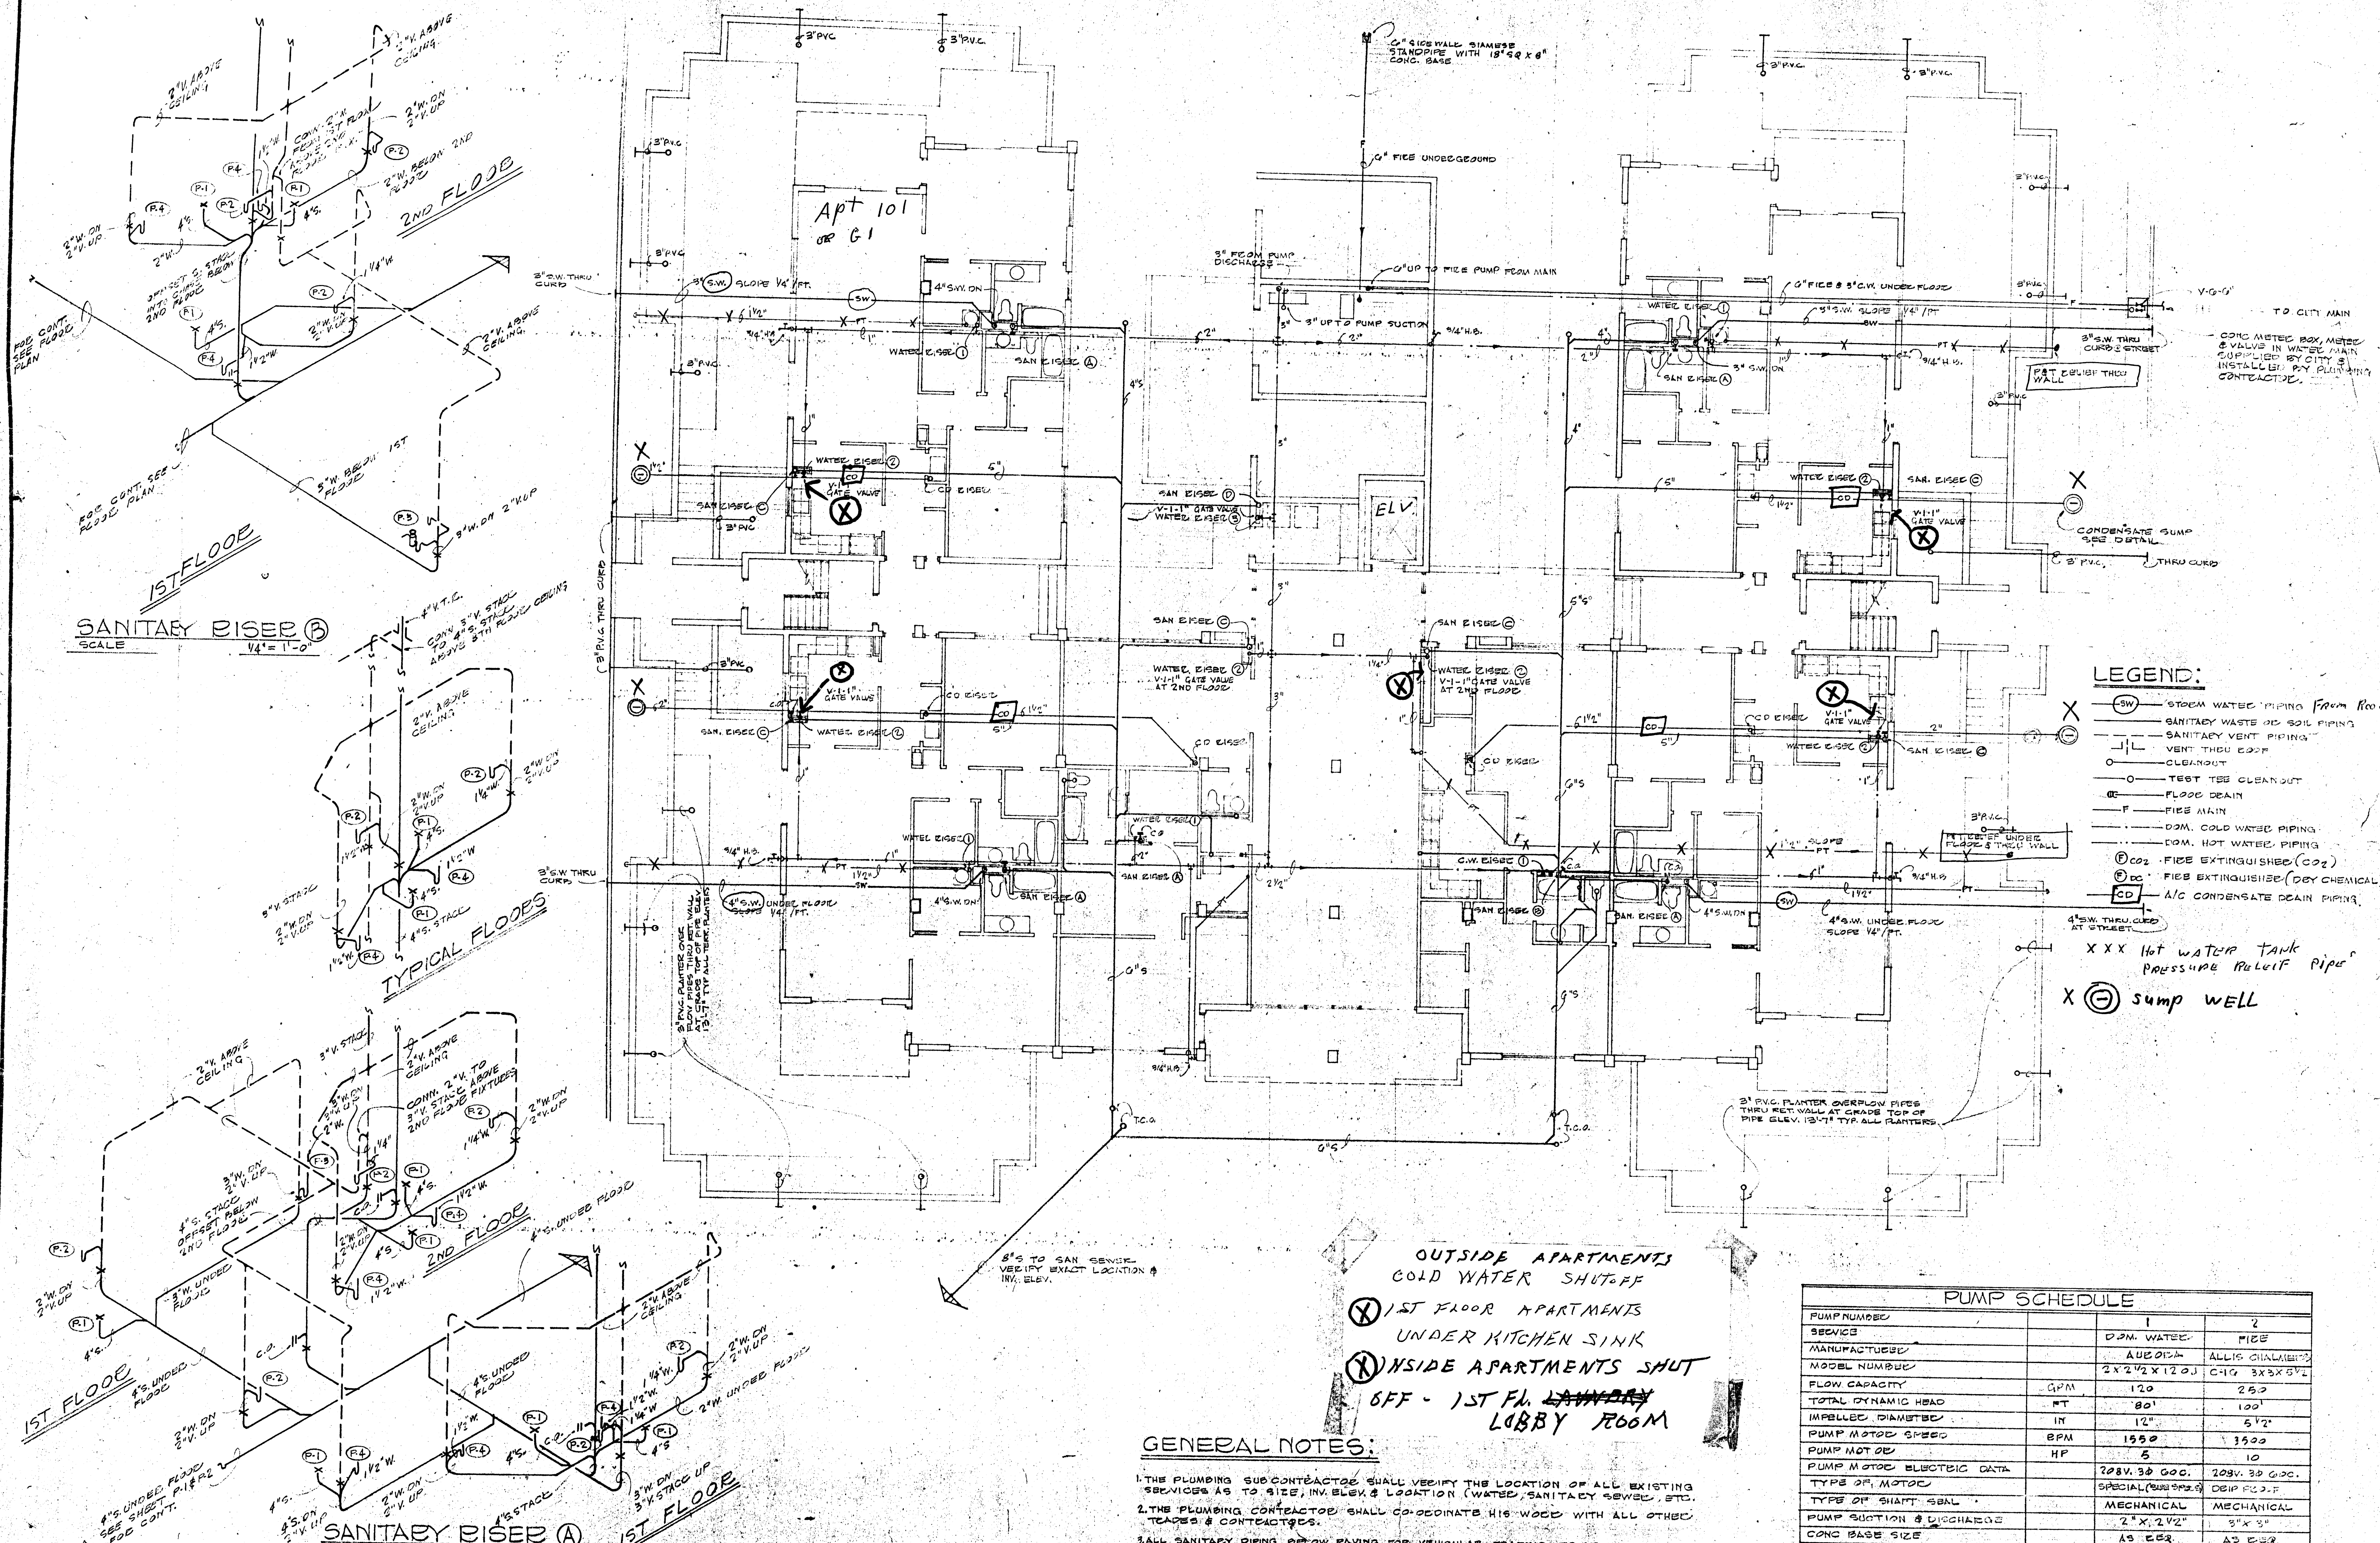

**SANITARY RISER (B)**  
 SCALE 1/4" = 1'-0"

**SANITARY RISER (A)**  
 SCALE 1/4" = 1'-0"

- LEGEND:**
- ⊖ SW - COLD WATER PIPING FROM FLOOR
  - ⊖ - SANITARY WASTE OR SOIL PIPING
  - ⊖ - SANITARY VENT PIPING
  - ⊖ - VENT THRU ROOF
  - ⊖ - CLEANOUT
  - ⊖ - TEST TEE CLEANOUT
  - ⊖ - FLOOR DRAIN
  - ⊖ - FIRE MAIN
  - ⊖ - C.W.M. COLD WATER PIPING
  - ⊖ - H.W.M. HOT WATER PIPING
  - ⊖ - CO2 - FIRE EXTINGUISHER (CO2)
  - ⊖ - FIB EXTINGUISHER (DEY CHEMICAL)
  - ⊖ - A/C CONDENSATE DRAIN PIPING
  - XXX - Hot water tank pressure relief pipe
  - ⊖ - sump well

**OUTSIDE APARTMENTS**  
 COLD WATER SHUTOFF  
 ⊖ 1ST FLOOR APARTMENTS  
 UNDER KITCHEN SINK  
 ⊖ INSIDE APARTMENTS SHUT  
 OFF - 1ST FL. LANNERY  
 LOBBY ROOM

**GENERAL NOTES:**

1. THE PLUMBING SUB CONTRACTOR SHALL VERIFY THE LOCATION OF ALL EXISTING SERVICES AS TO SIZE, INV. ELEV. & LOCATION (WATER, SANITARY SEWER, ETC.)
2. THE PLUMBING CONTRACTOR SHALL CO-ORDINATE HIS WORK WITH ALL OTHER TRADES & CONTRACTORS.
3. ALL SANITARY PIPING BELOW PAVING FOR VEHICULAR TRAFFIC TO BE EXTRA HEAVY CASTIRON OR EXTRA HEAVY VITRIFIED CLAY PIPE.

PUMP SCHEDULE			
PUMP NUMBER	1	2	
SERVICE	D.M. WATER	FIRE	
MANUFACTURER	AUBURN	ALLIS CHALMERS	
MODEL NUMBER	2X2 1/2 X 12 1/2	C-10 3X3X8 1/2	
FLOW CAPACITY	GPM	120	250
TOTAL DYNAMIC HEAD	FT	80'	100'
IMPELLER DIAMETER	IN	12"	5 1/2"
PUMP MOTOR SPEED	BPM	1550	1750
PUMP MOTOR	HP	5	10
PUMP MOTOR ELECTRIC DATA	208V. 3Ø 0.00.	208V. 3Ø 0.00.	
TYPE OF MOTOR	SPECIAL (SPECIAL)	DEEP FLO. F.	
TYPE OF SHAFT SEAL	MECHANICAL	MECHANICAL	
PUMP SUCTON & DISCHARGE	2" X 2 1/2"	3" X 3"	
CONC. BASE SIZE	AS EQD.	AS EQD.	

SHEET NO. 11  
 OF 14